
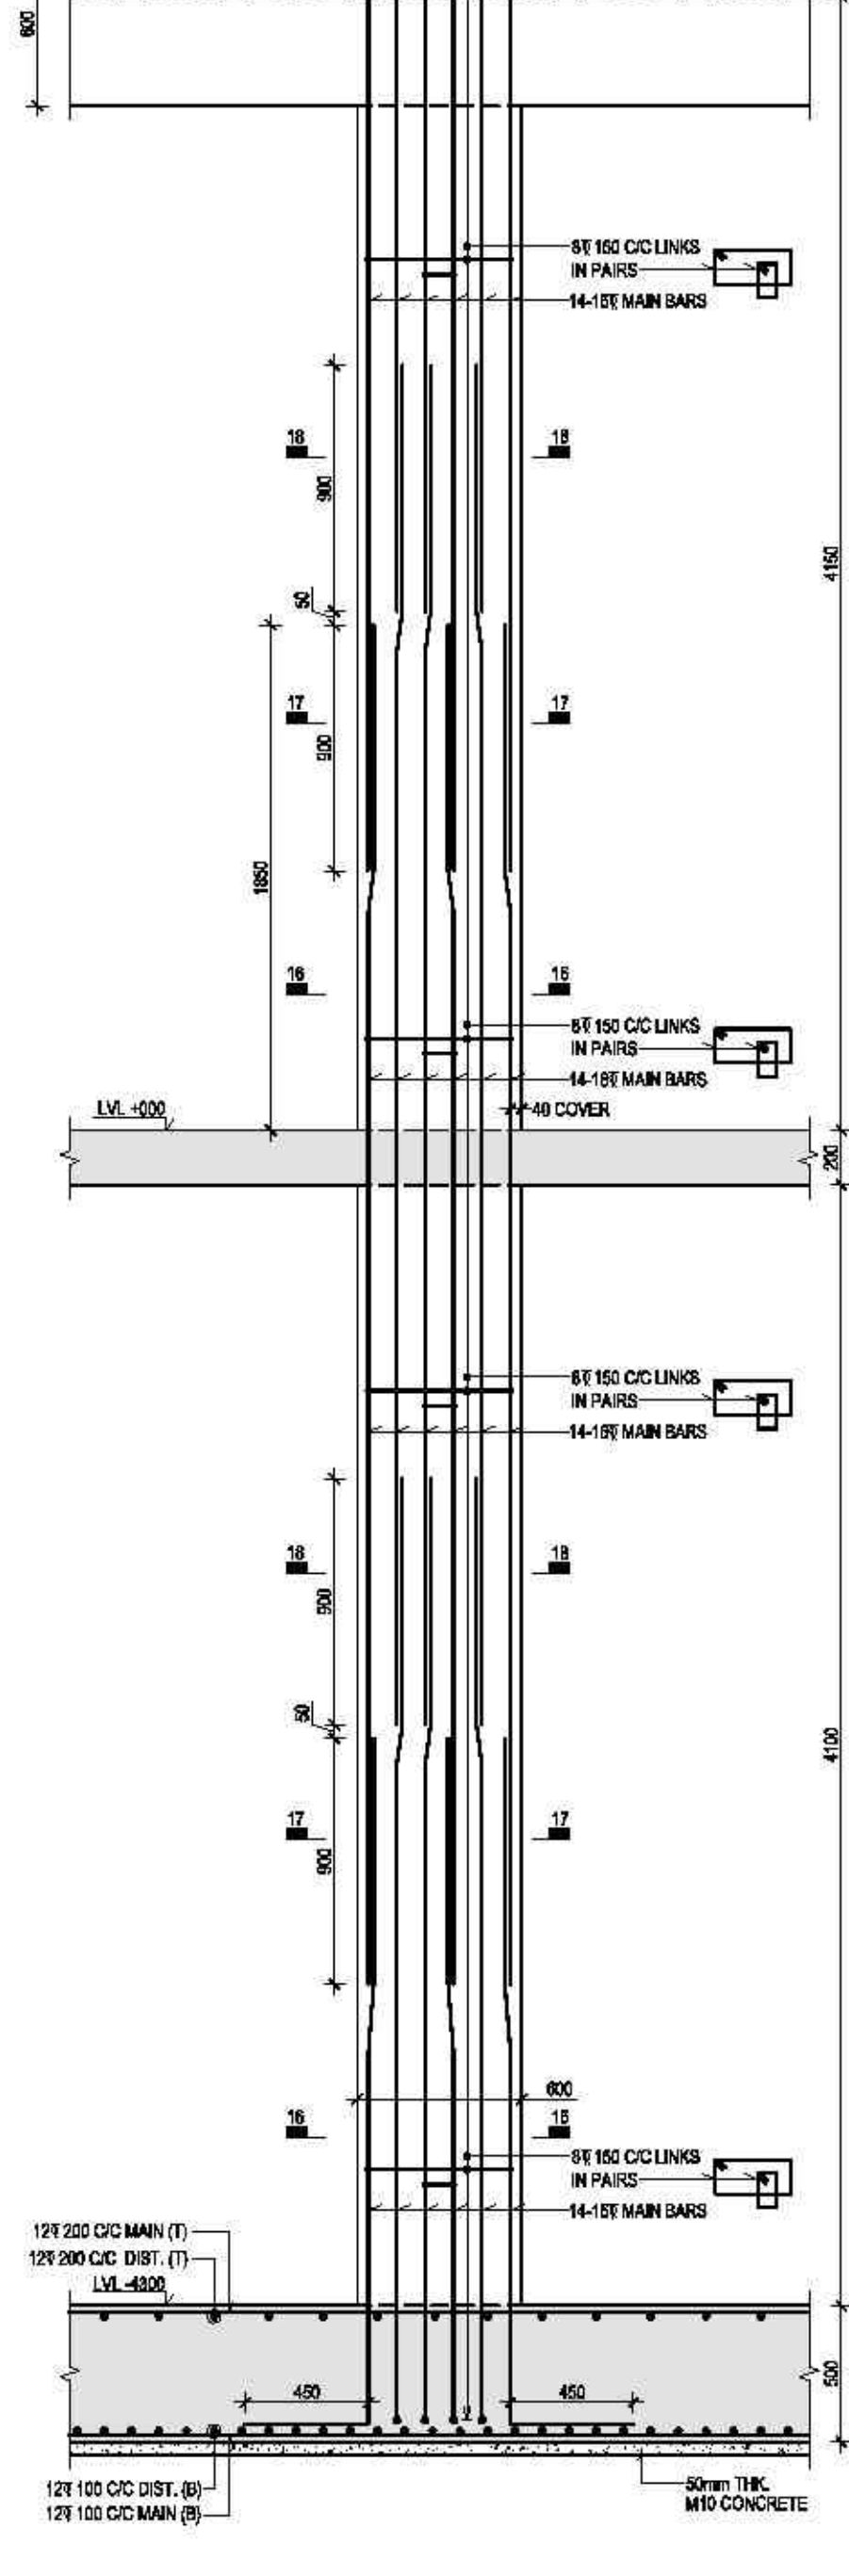
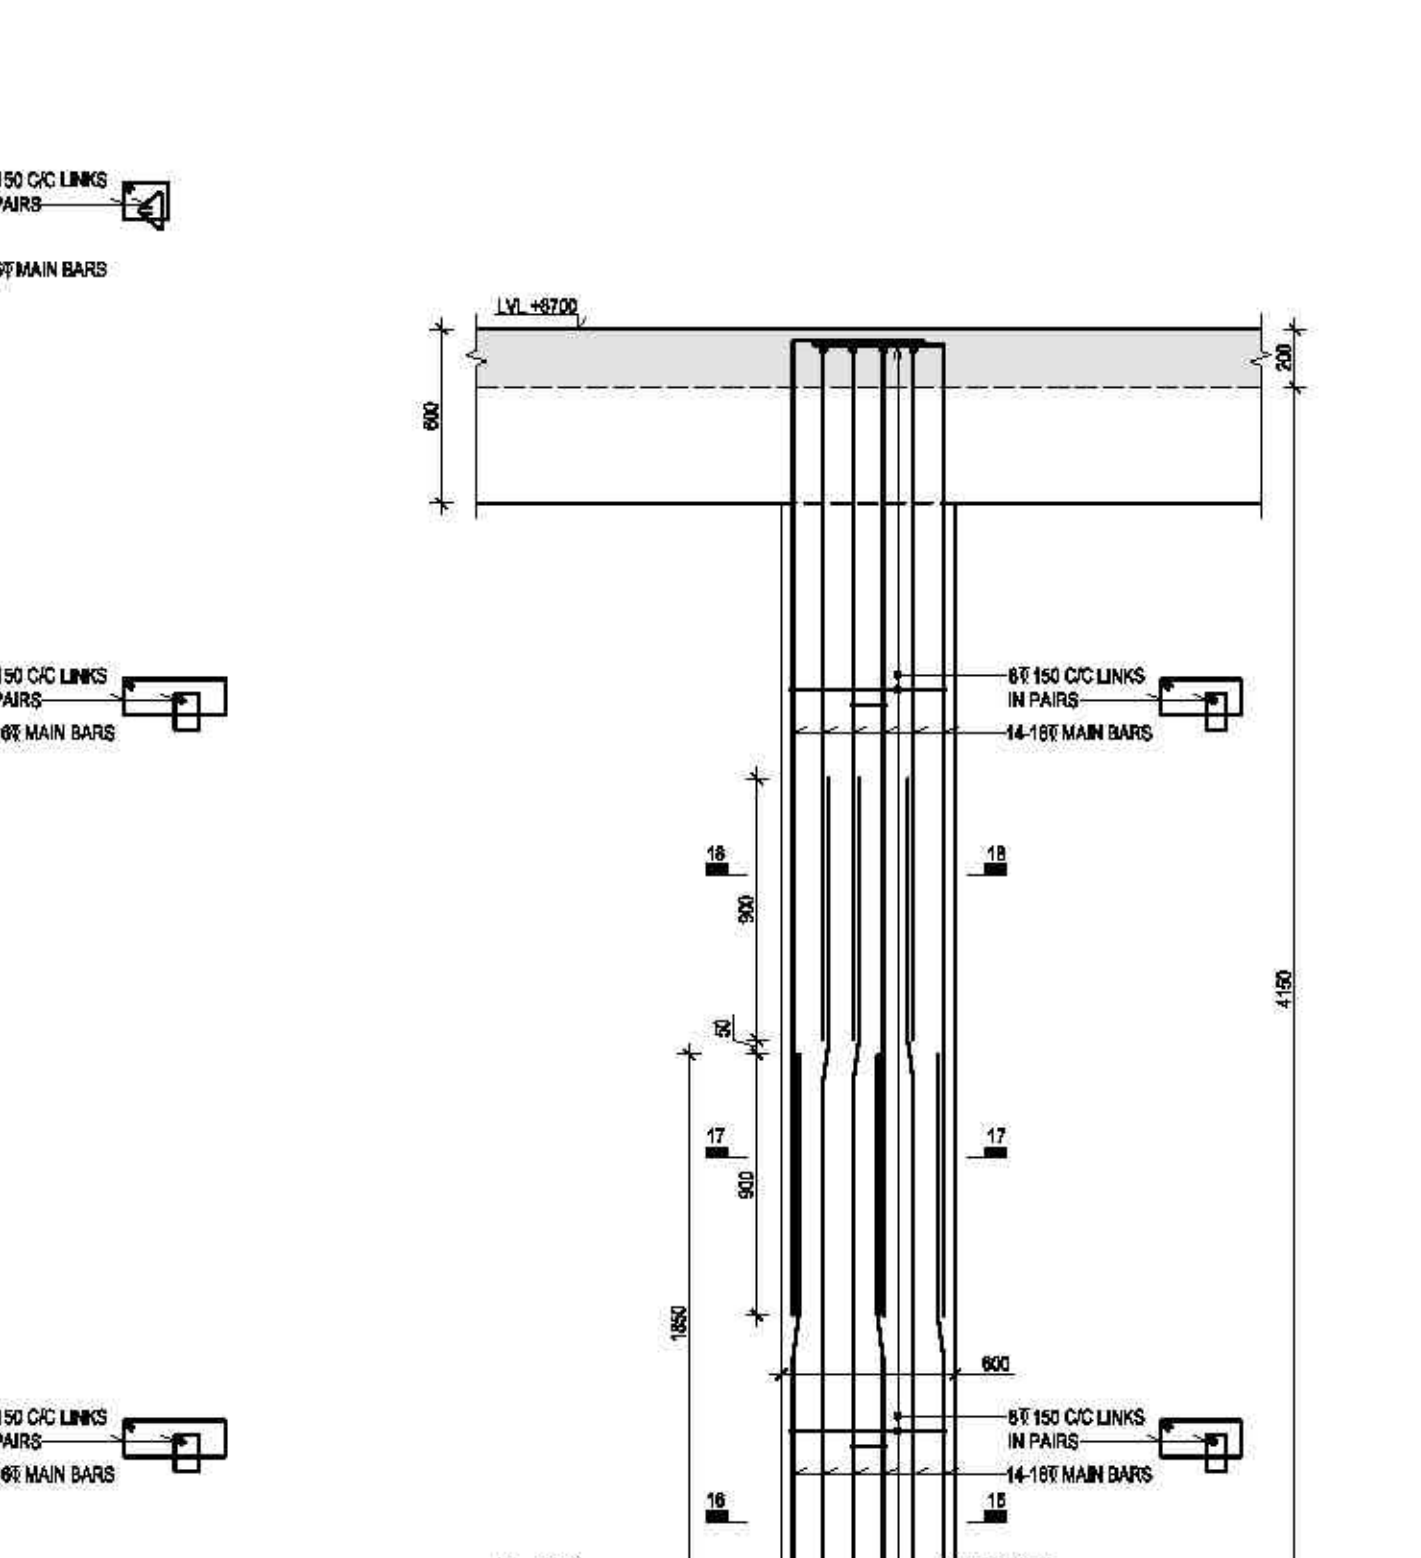
 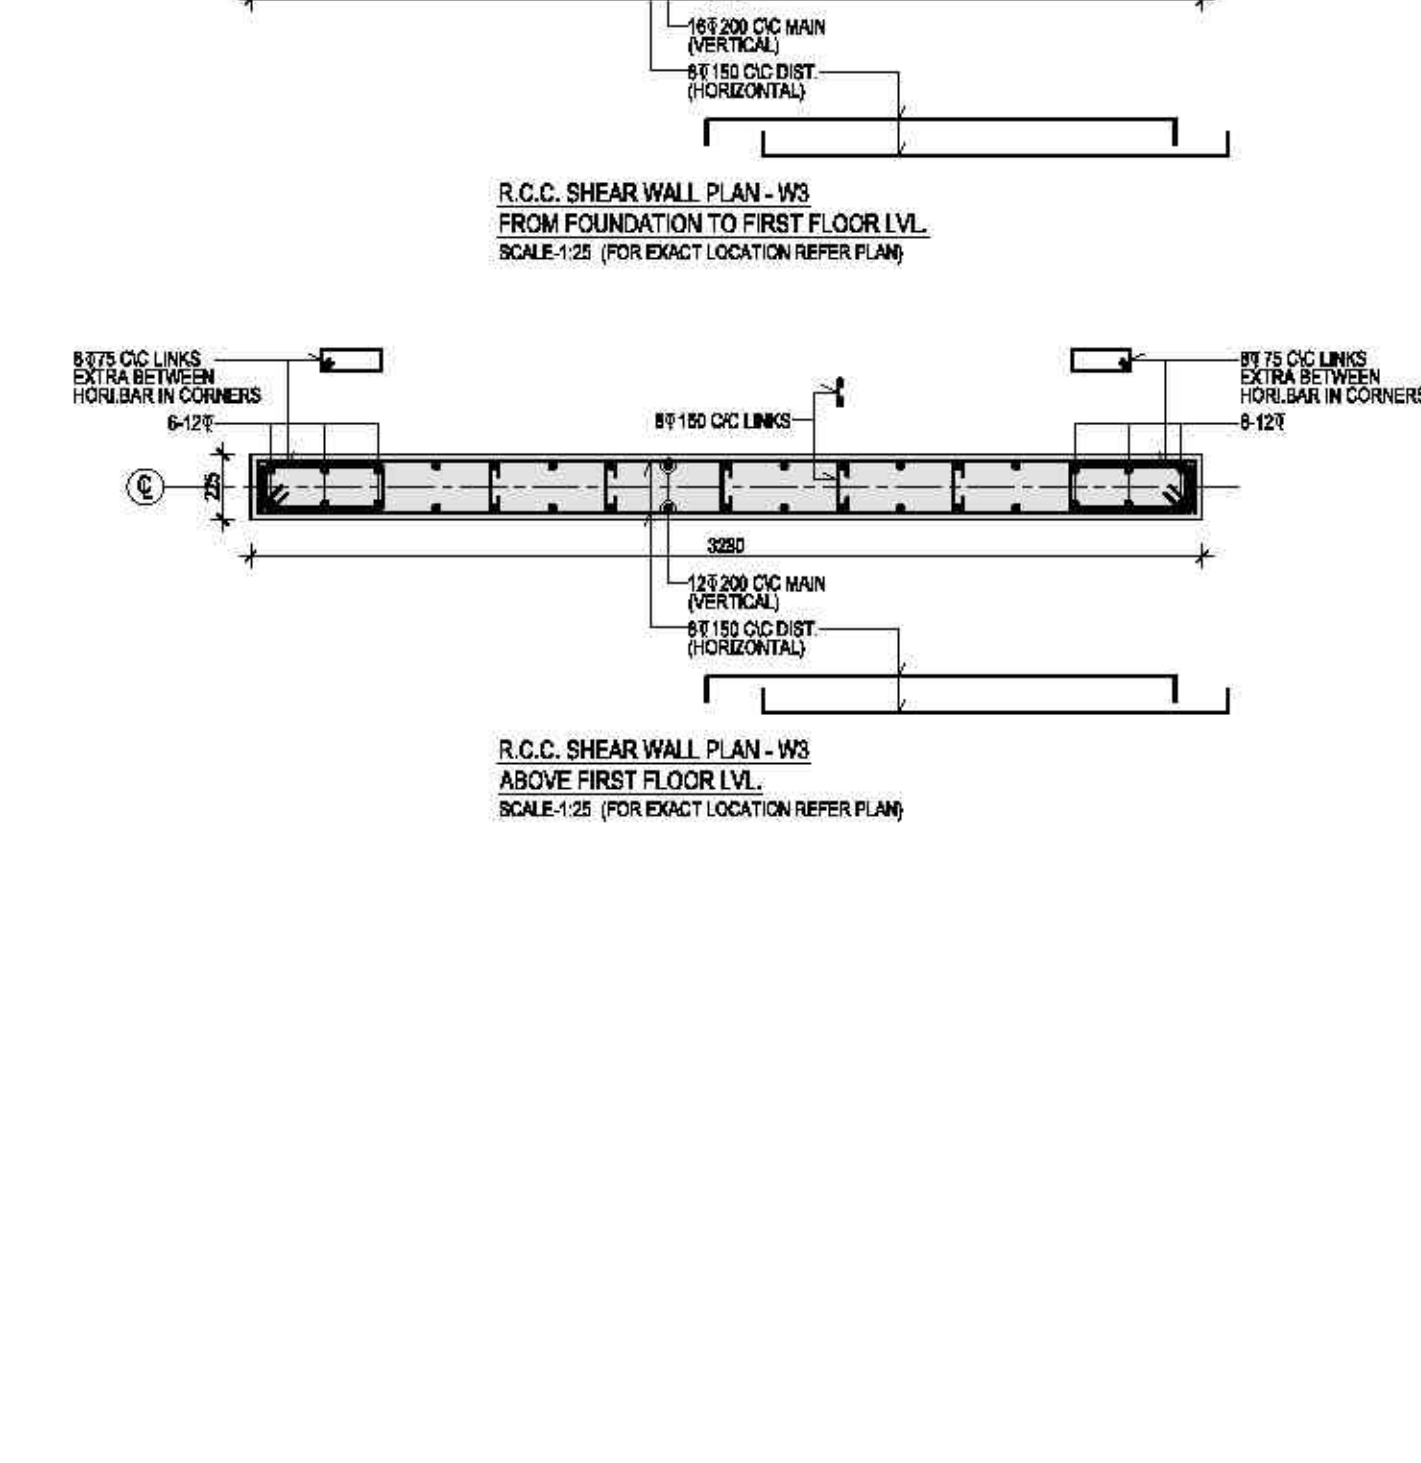

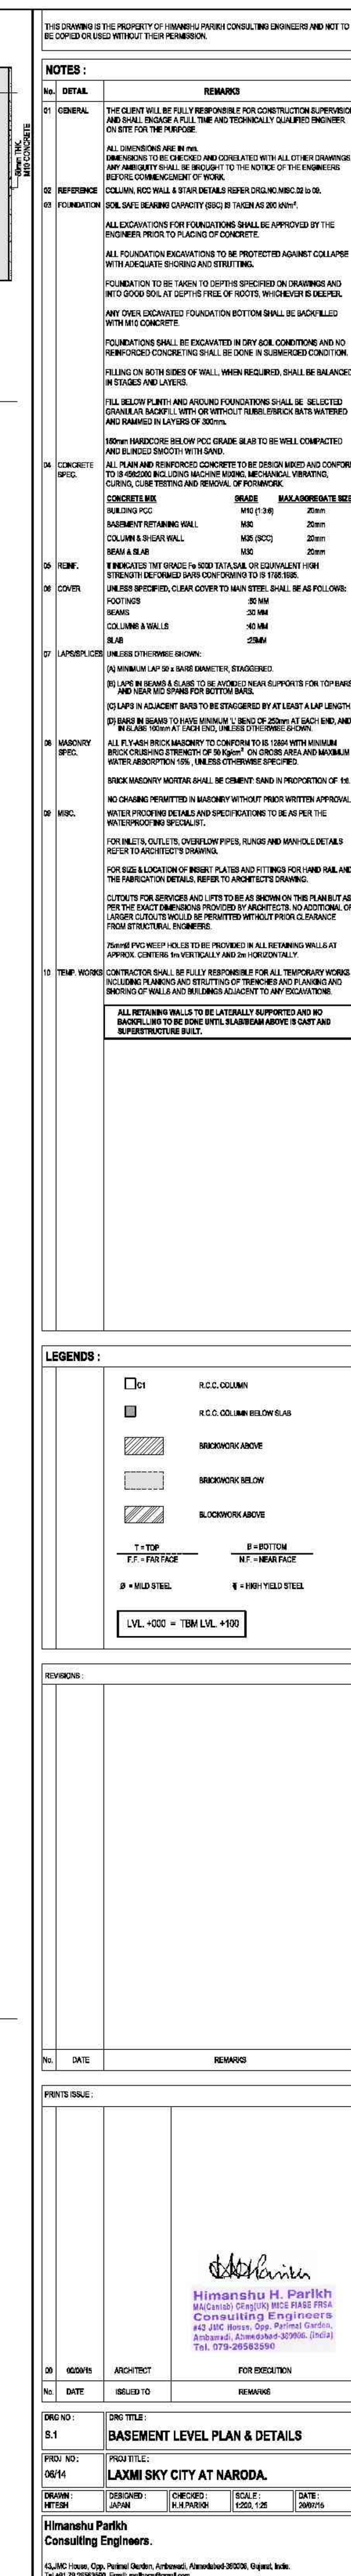


PRINTS ISSUE:					
					
		Himanshu Parikh Manager, Quality Dept., P&ID Consulting Engineers Pvt. Ltd., 2nd Floor, C-9, Karampada, JALANDHAR - 150006 (INDIA) Tel.: 019-26543850			
DR	ISSUED BY	ARCHITECT	FOR EXECUTION		
NO.	DATE	ISSUED TO	REMARKS		
DWG NO :	Dwg TITLE :				
MISC 02	COLUMN & R.C.C WALL DETAILS				
PRIJ NO :	PRIJ TITLE :				
06/14	LAXMI SKY CITY AT NARODA.				
DRAWING METER	DESIGNED : JOHAN	CHECKED : K.N.KADAMBA	SCALE : 1:100, 1:25	DATE : 2009/11	
Himanshu Parikh Consultant Engineer					

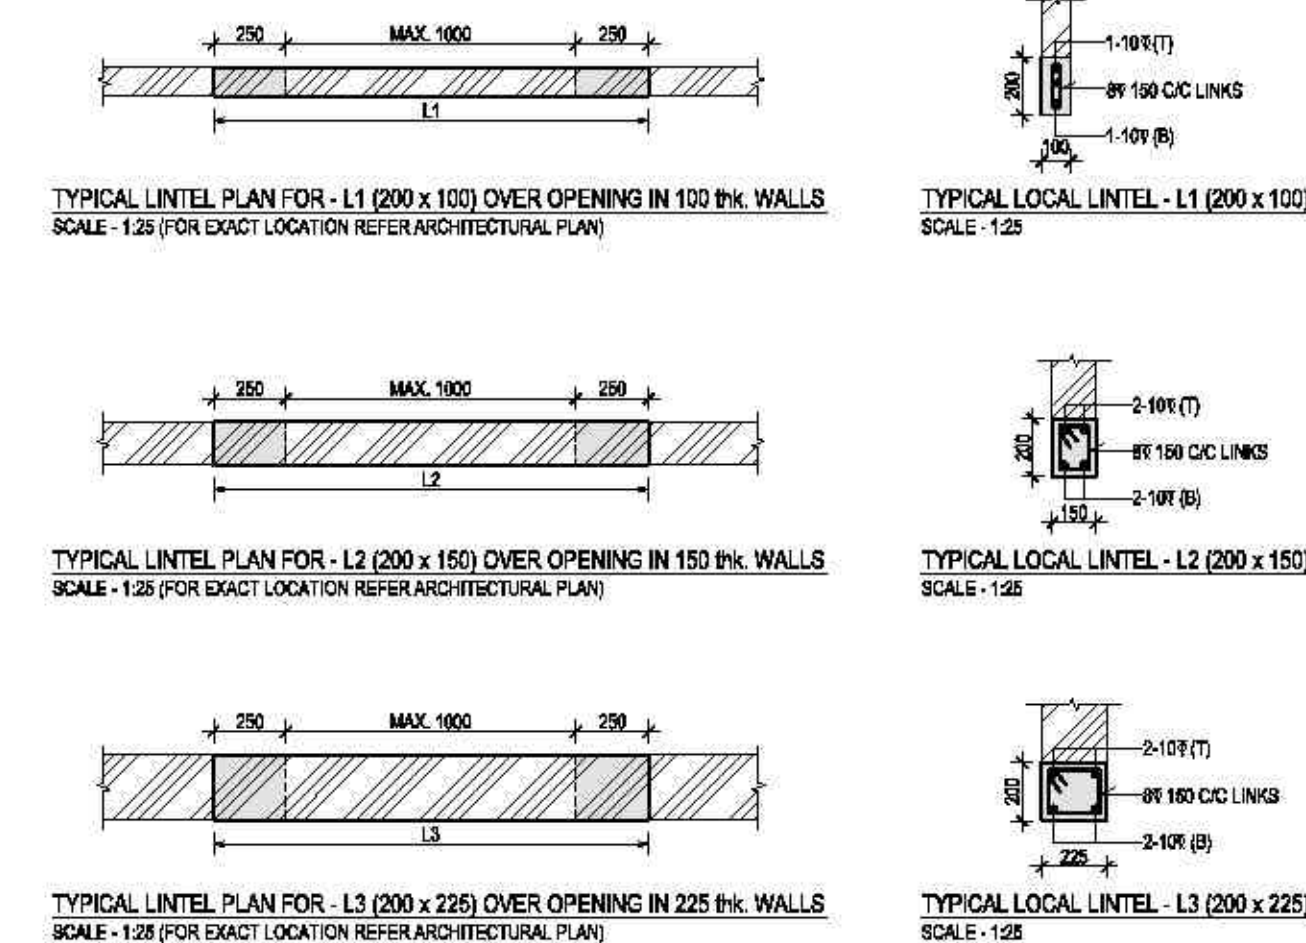

[illegible]

STAIRCASE SETTING OUT AS PER
ARCHITECTURAL DETAIL DRAWINGS.

LEGENDS :

	R.C.C COLUMN
	R.C.C COLUMN BELOW SLAB
	BLOCKWORK ABOVE
	BLOCKWORK BELOW
	BLOCKWORK ABOVE

T = TOP	B = BOTTOM
EF = EXTERIOR FACE	IF = INTERIOR FACE

Ø = MILD STEEL I = HIGH YIELD STEEL

LVL. +200 = TBM LVL. +100

REVISIONS:	
------------	--

No.	DATE	REMARKS
-----	------	---------

PRINTS ISSUE :

Himanshu H. Parikh
MA(Certificd) CEng(UK) MICE FIASS FRESA
Consulting Engineers
413 JMC House, Opp. Parnell Garden,
Ambarnadi, Ahmedabad-380003, (India)
Tel. 079-26563590

00	00000000	ARCHITECT	
01	00000000	ARCHITECT	

DRO NO :	DRO TITLE :
----------	-------------



PROJ NO:	PROJ TITLE:
----------	-------------


Himanshu Parkh
Consulting Engineers.

43, SAC House, Opp. Petrol Garden, Ambewadi, Ahmedabad-380006, Gujarat, India.

SIZE OF RCC WALL	
RCC WALL TYPE	RCC WALL SIZE
W1	1600 x 225 (STRAIGHT)
W2	2000 x 225 (STRAIGHT)
W3	3220 x 225 (STRAIGHT)
W4	950 x 225 (STRAIGHT)
W5	950 x 225 (STRAIGHT)

SIZE OF COLUMNS	
COLUMN TYPE	COLUMN SIZE
C1	750 x 300
C2	600 x 300
C3	950 x 225
C4	450 Ø
C5	600 x 250
C6	750 x 300
C7	600 x 300
C8	600 x 250

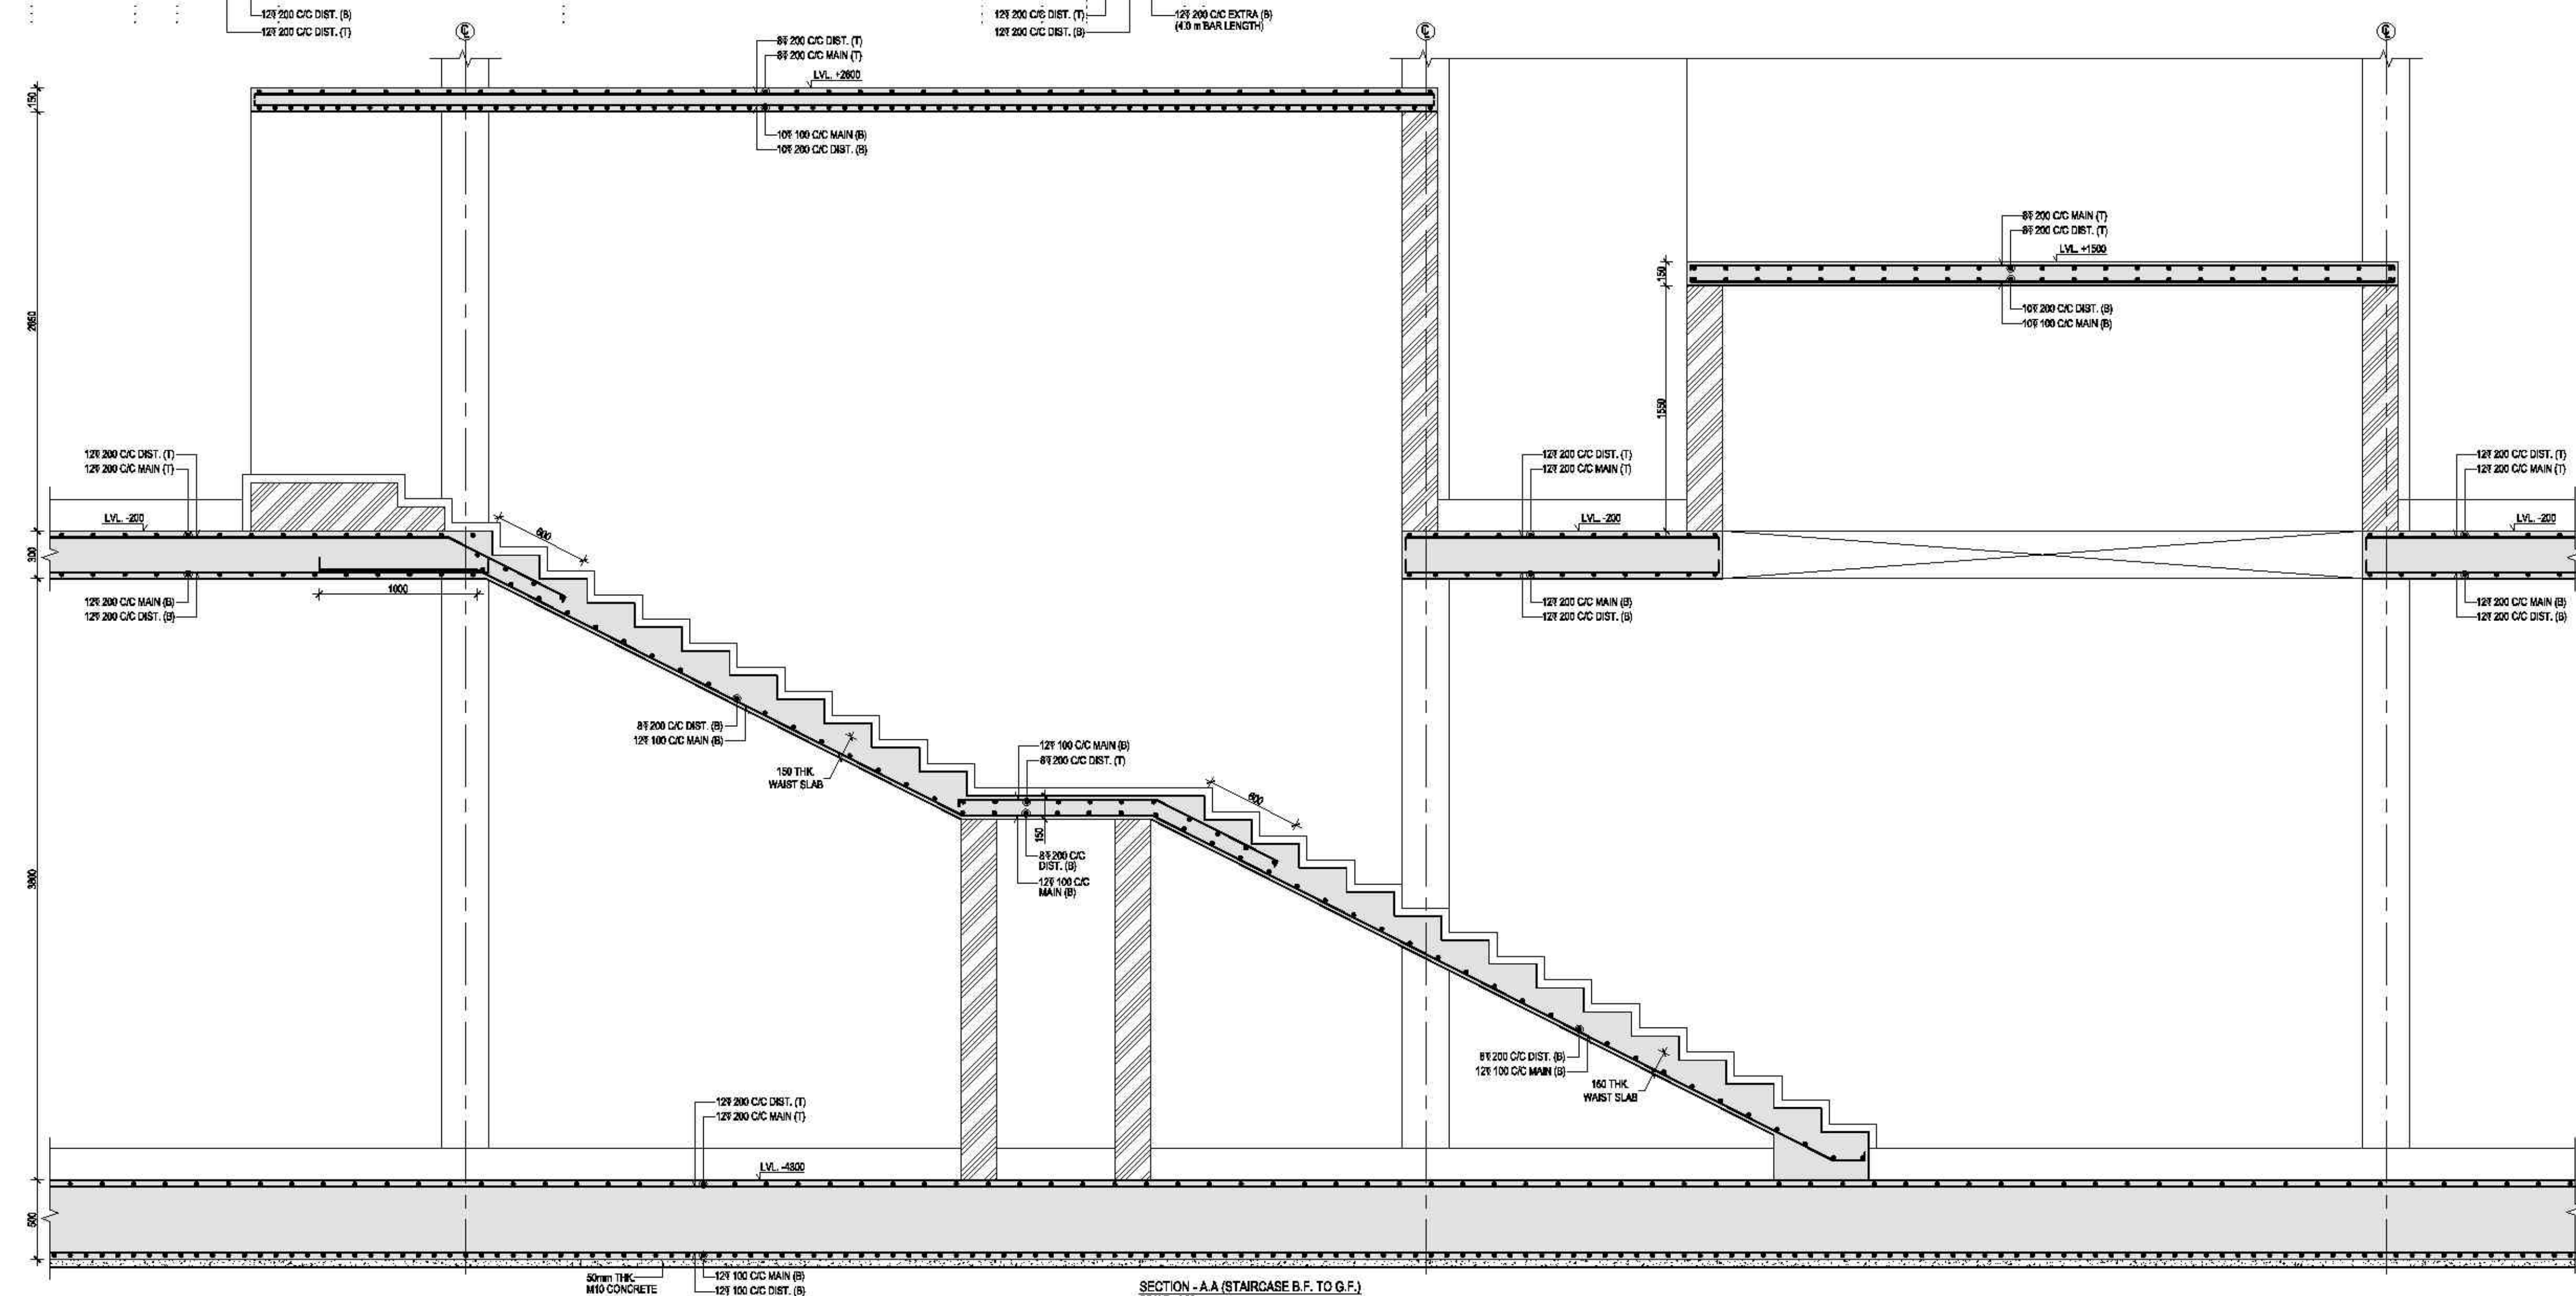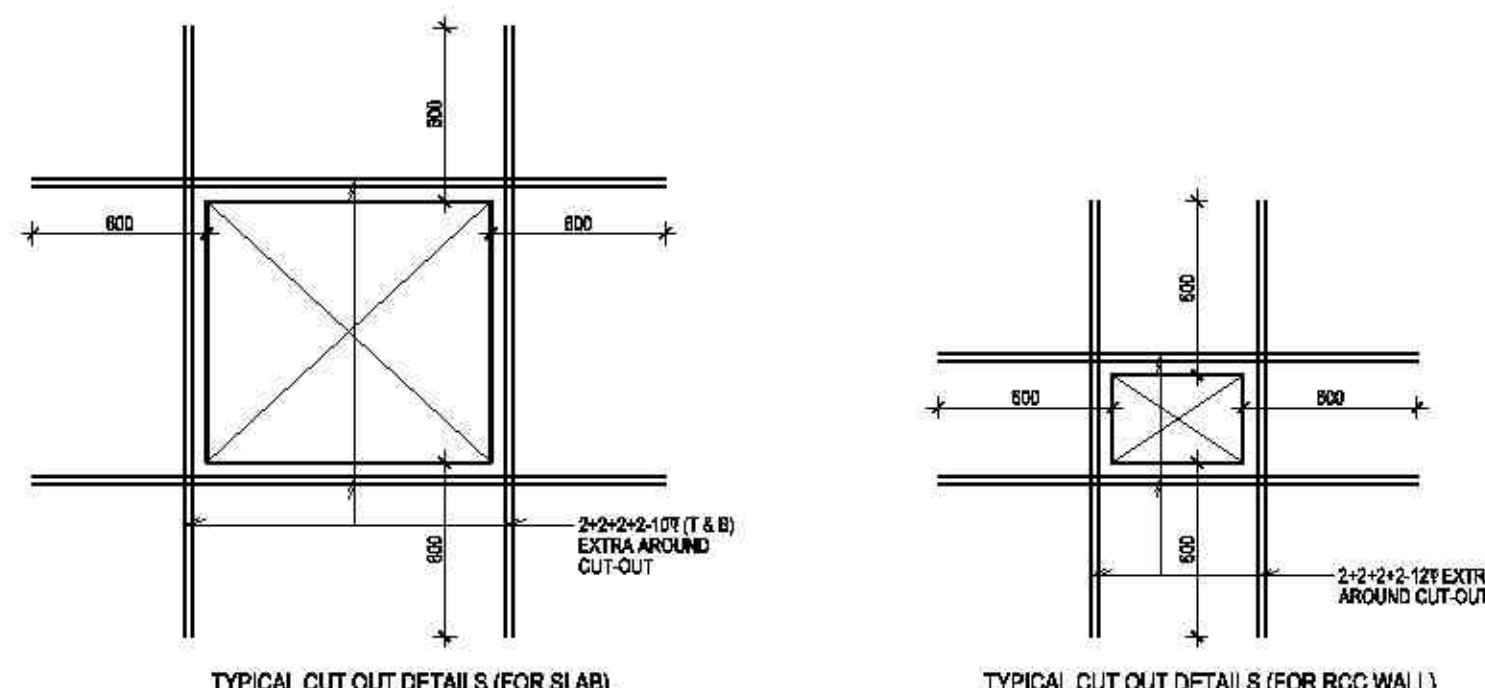

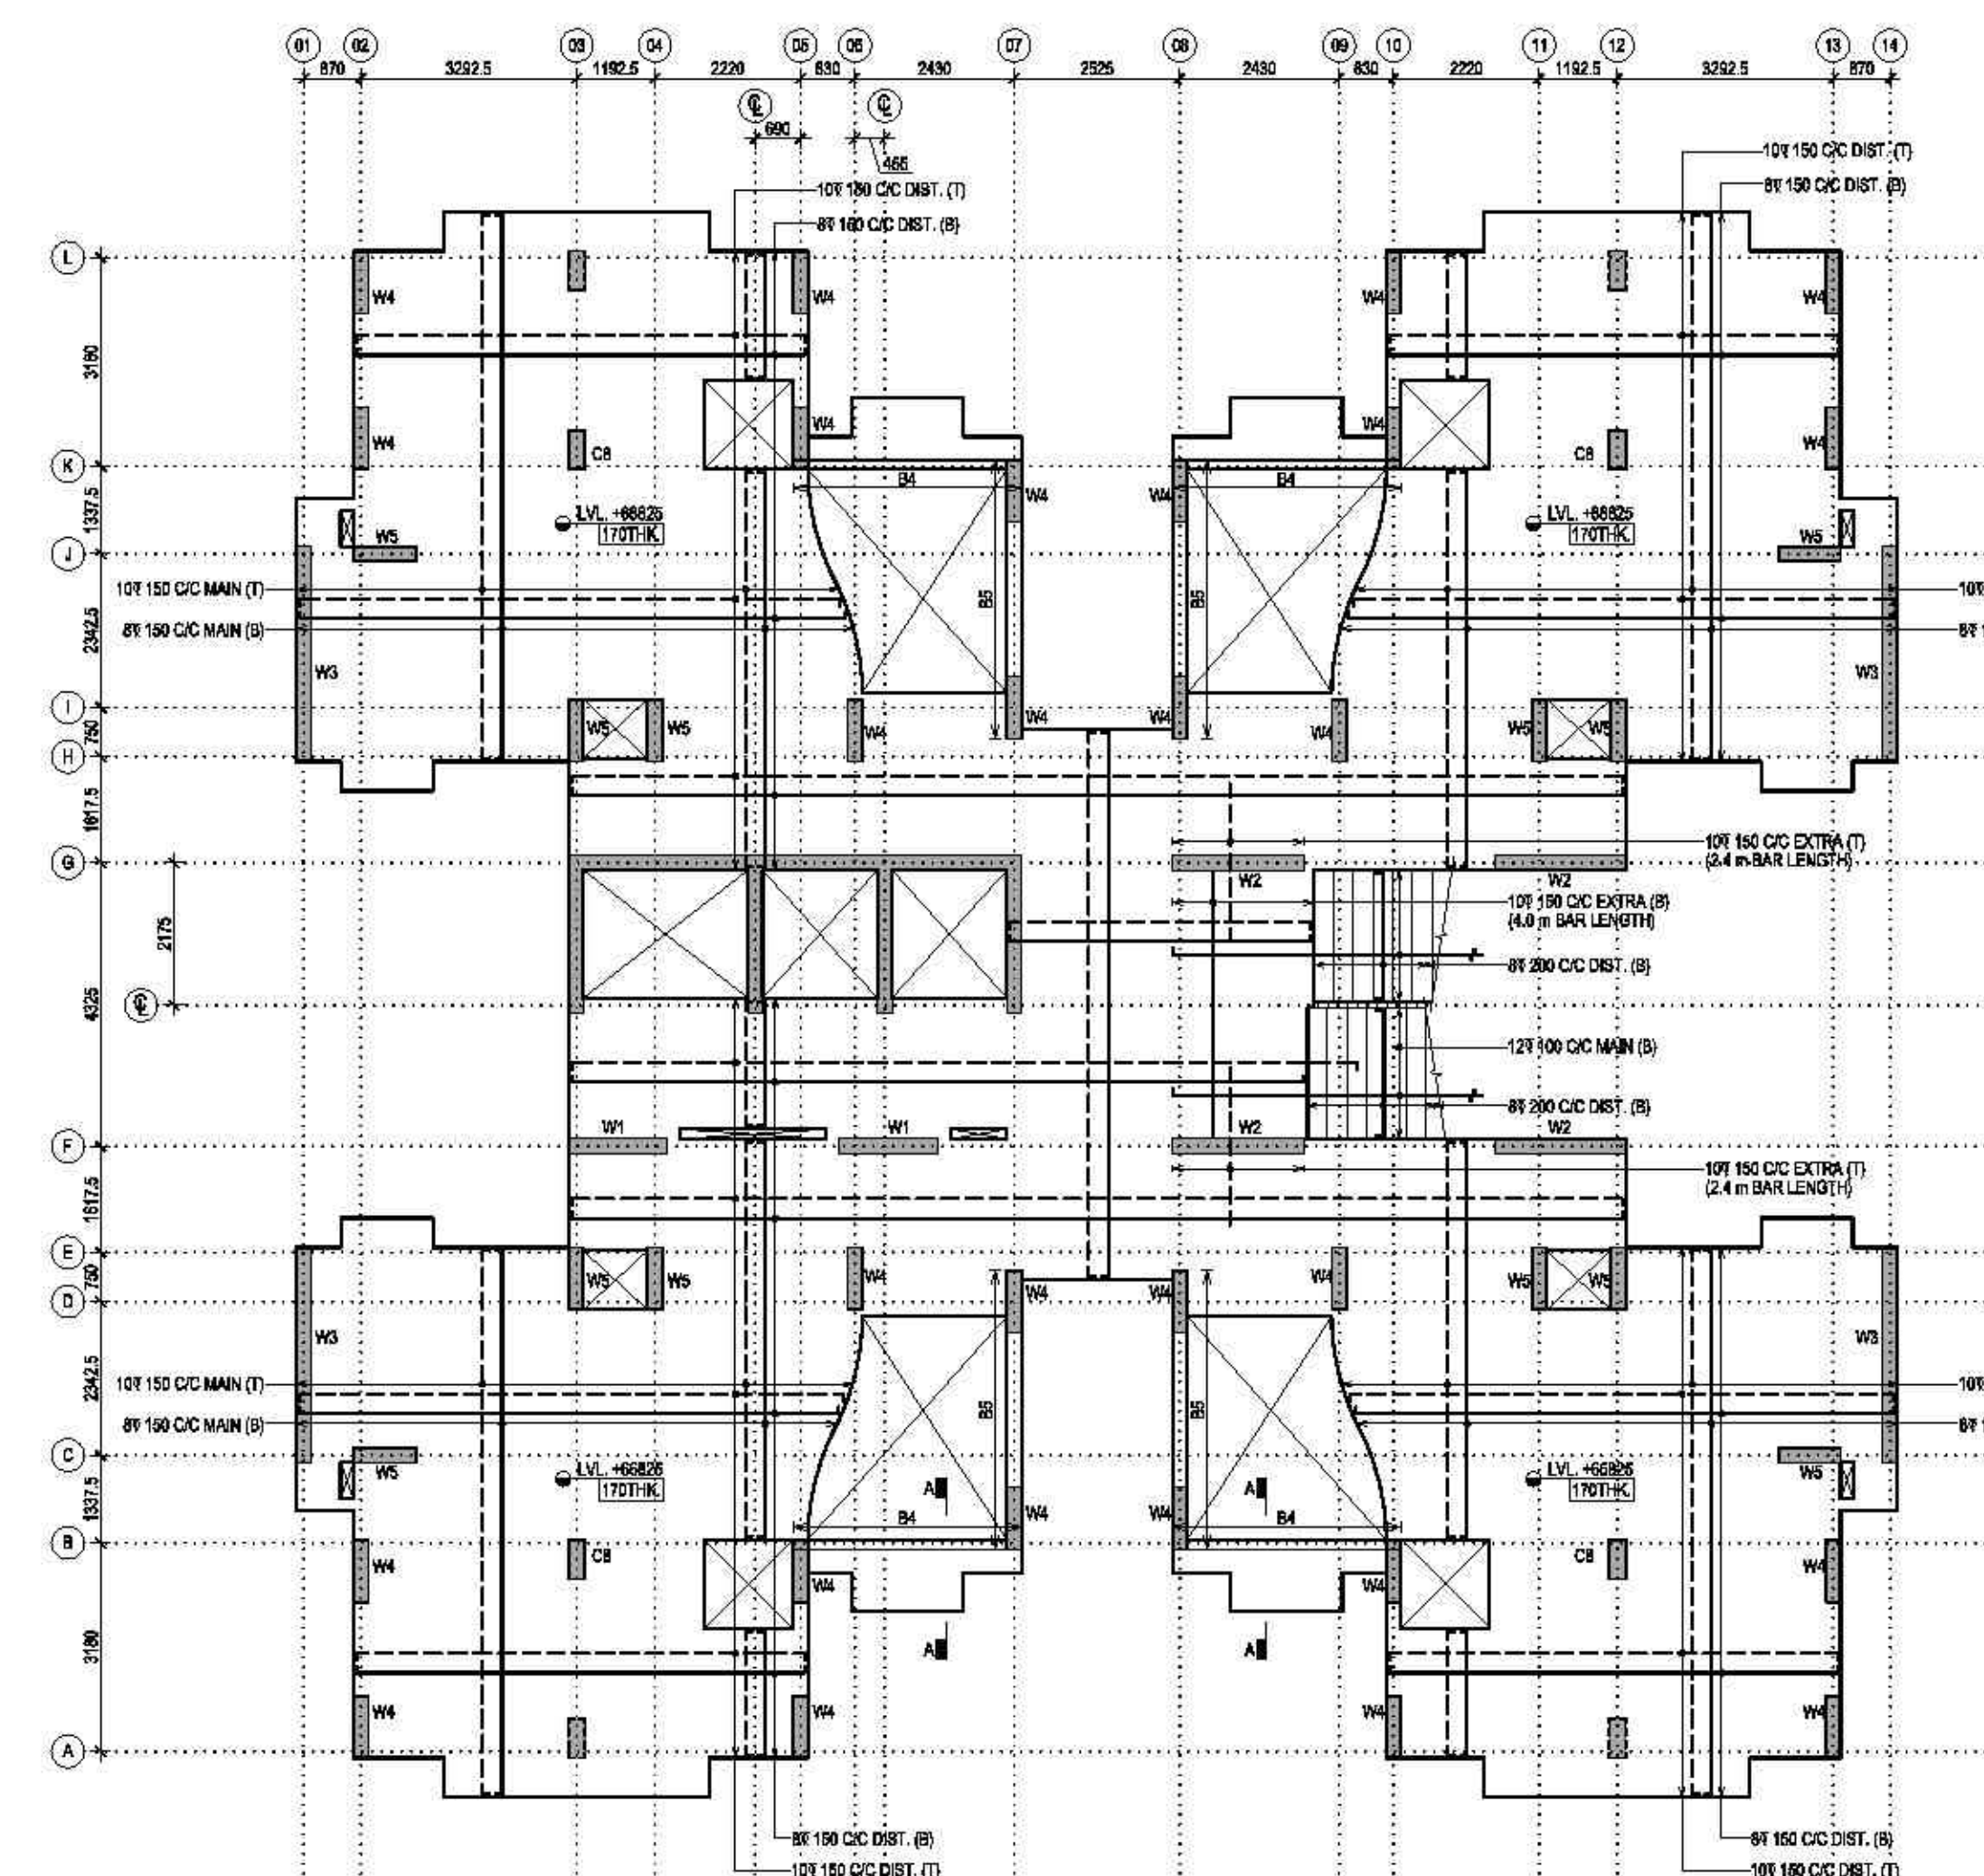

PENT HOUSE FLOOR LEVEL PLAN (+66825 LVL.)

200

2-10T (T)


8T150 CPC LINKS

225

2-10T (B)

TYPICAL LOCAL LINTEL - L3 (200 x 225)

LANDING LEVEL PLAN

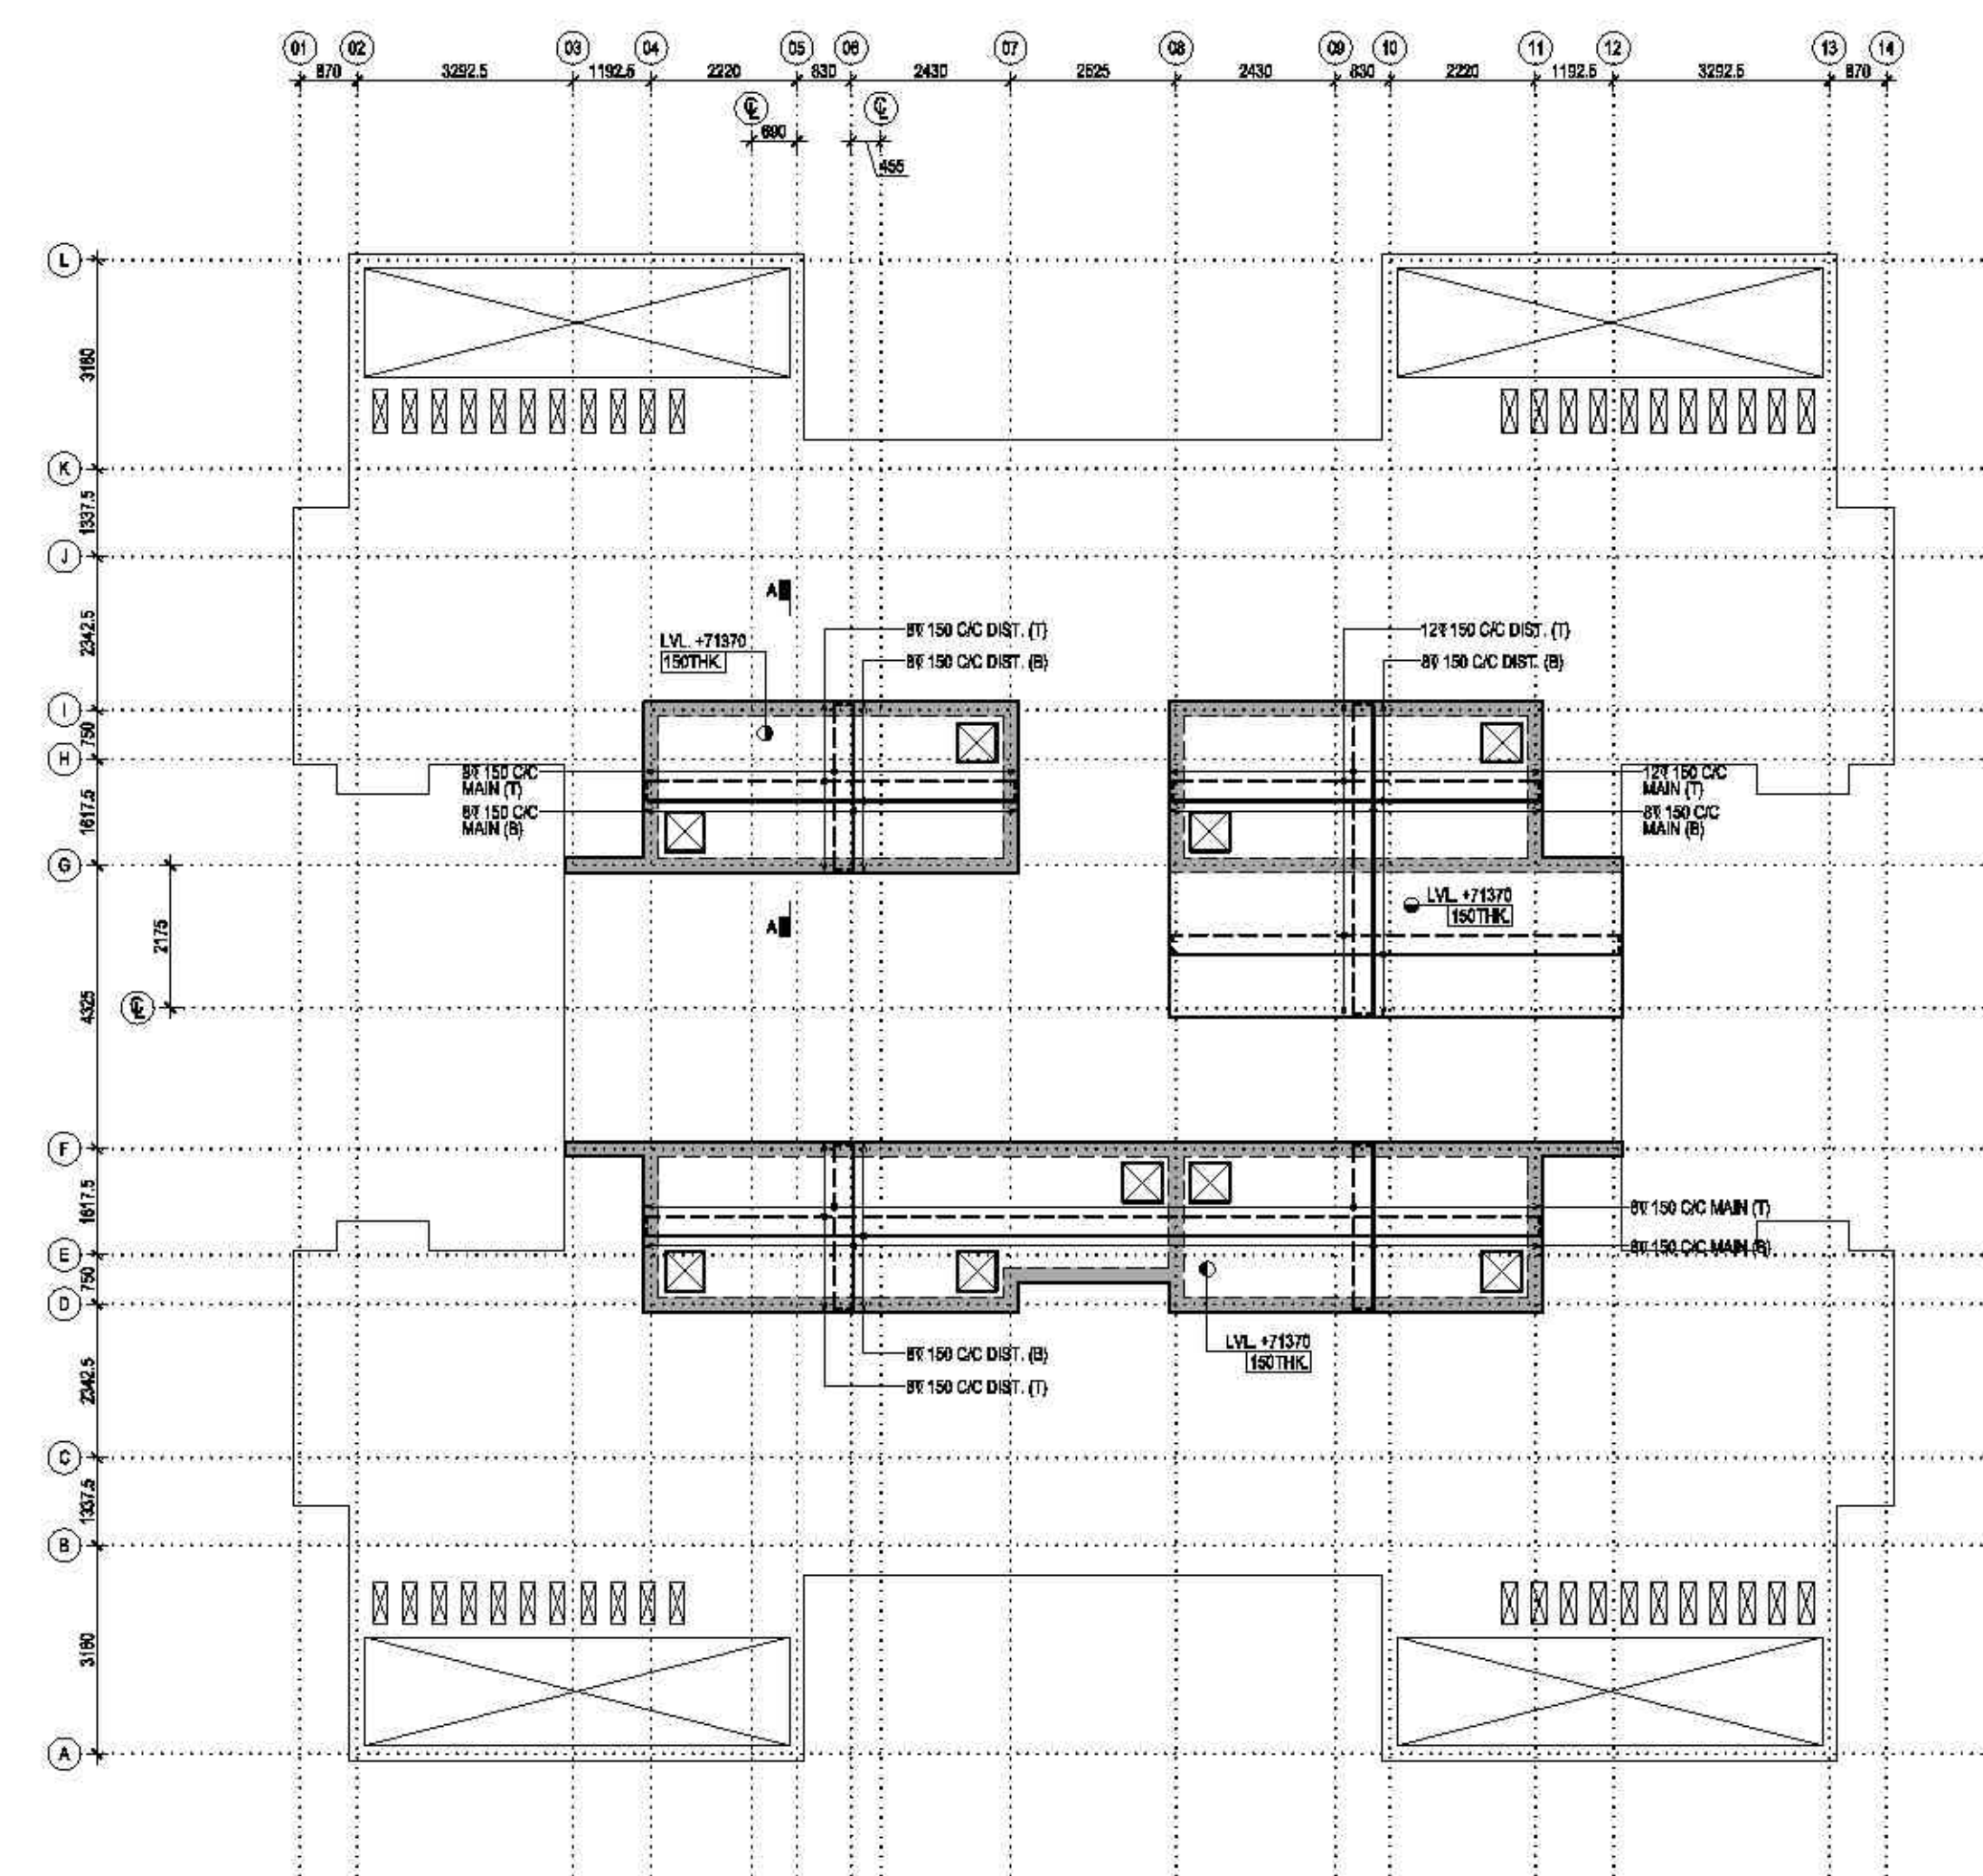

TYPICAL CUT OUT DETAILS (FOR SLAB)

SECTION - Z-Z
CROSS SECTION

Himanshu Parikh
Consulting Engineers.